


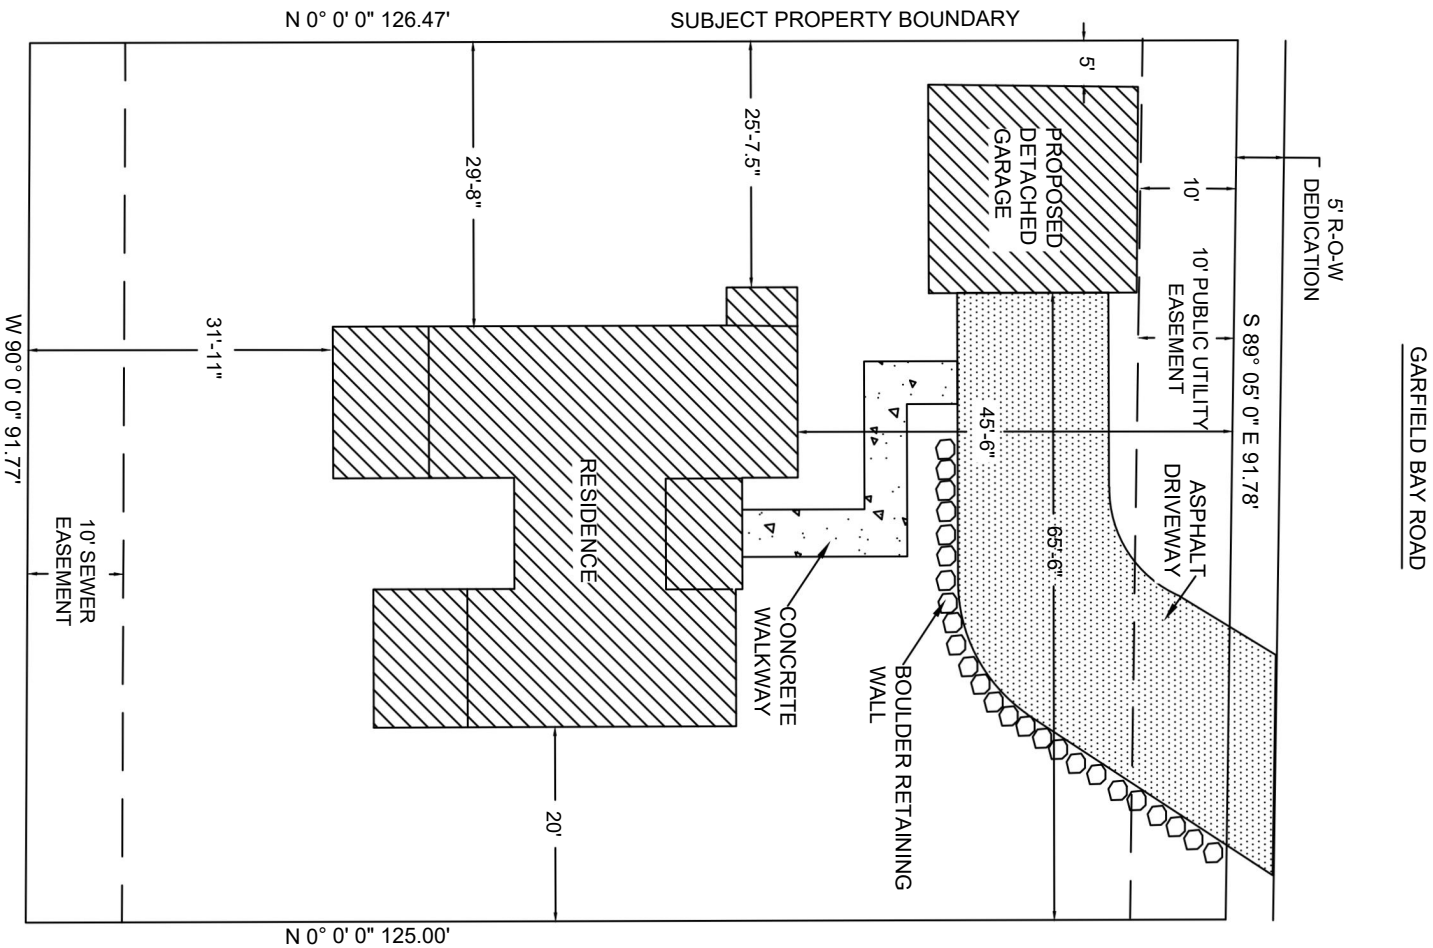



Clearwater Engineering
A Limited Liability Company
clearwaterengineeringidaho.com
P.O. Box 2006
Post Falls, ID 83877
Phone: 406.690.5249

MONARCH VISTA - LOT 1

SITE PLAN

PROJ. NO.:	REVISION:
CW201.X	
DWN. BY:	DATE:
NMC	
DATE:	BY:
10/6/25	
1 OF 1 SHEET	
C-1 DWG. NO.	